


SITE PLAN

by
ANDREW SPIEWAK LAND SURVEYOR, INC.
of

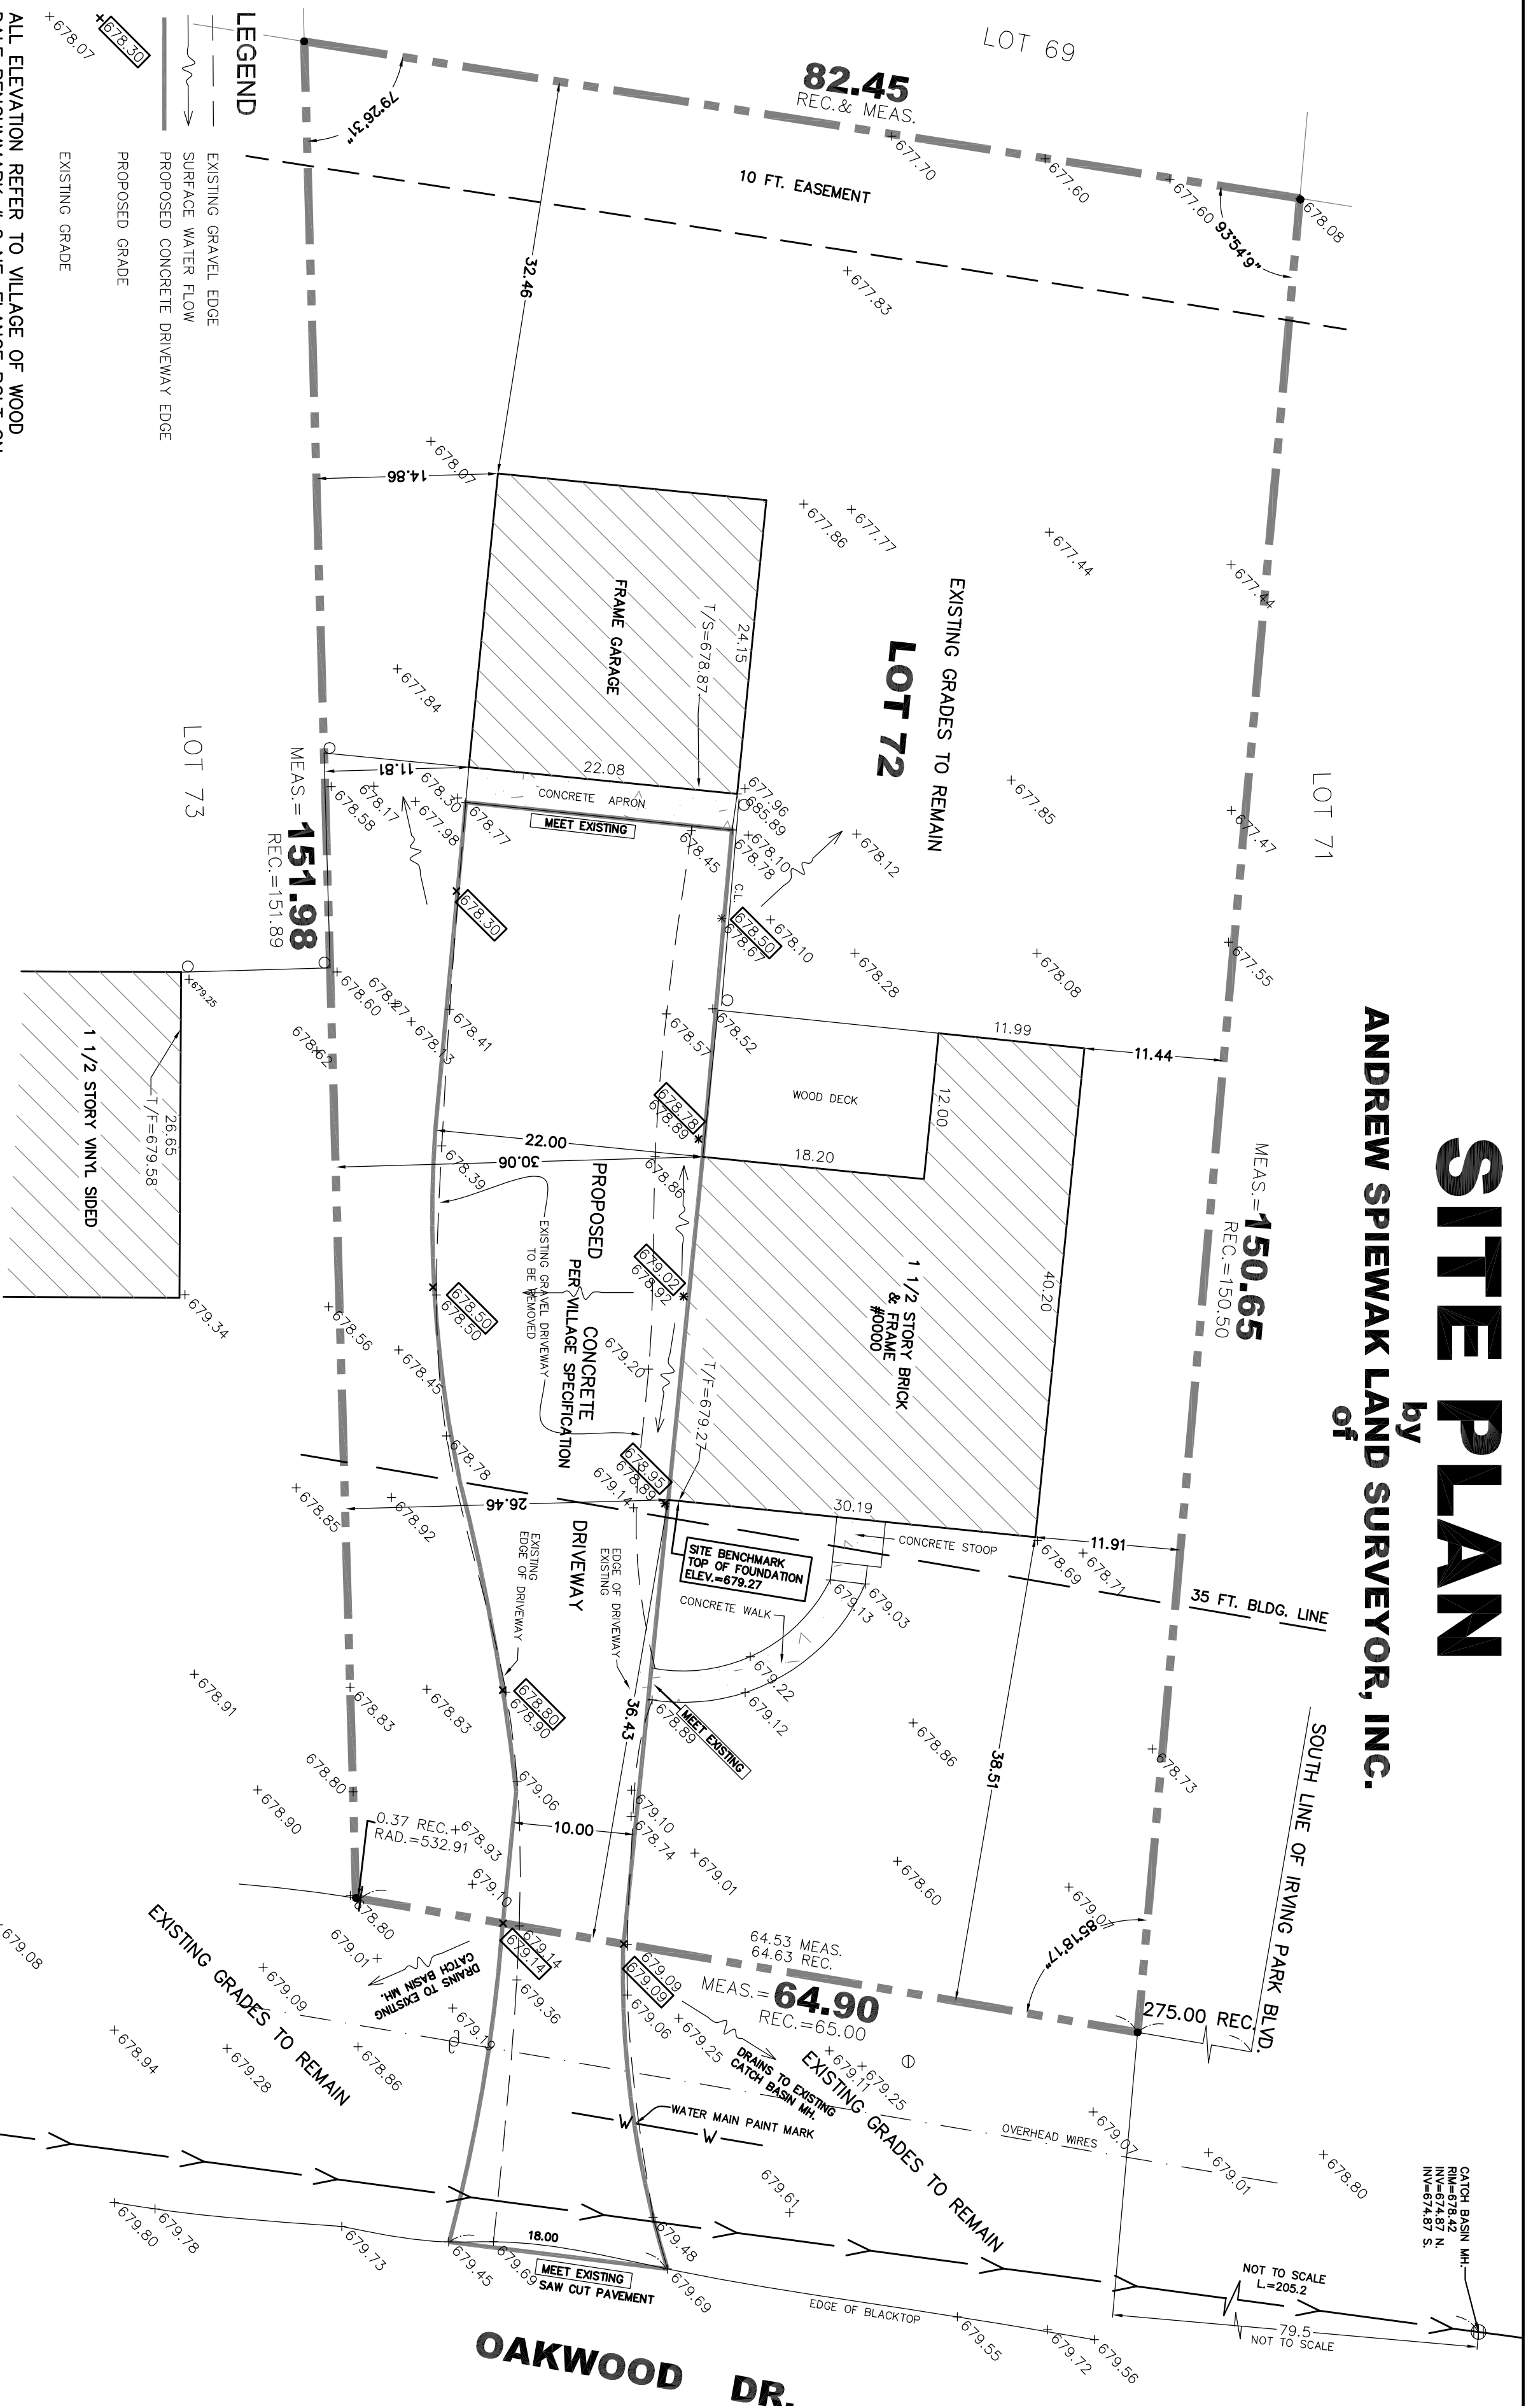

ALL ELEVATION REFER TO VILLAGE OF WOOD DALE BENCHMARK # 2 NE FLANGE BOLT ON THE SECOND FLOOR HYDRANT WEST OF WEDGEWOOD ON THE N. SIDE OF DEERPATH RD. ELEVATION 694.11


GENERAL NOTES:
1. THE LOCATION OF UNDERGROUND UTILITIES SHOWN HEREON IS BASED ONLY ON ABOVE GROUND EVIDENCE, TOGETHER WITH EVIDENCE FROM PLANS OBTAINED FROM UTILITY COMPANIES OR PROVIDED BY CLIENT. AND MARKINGS BY UTILITY COMPANIES OR OTHER APPROPRIATE SOURCES (IF NOTED HEREON). THE SURVEYOR MAKES NO GUARANTEE THAT THE UNDERGROUND UTILITIES SHOWN COMPRISE ALL SUCH UTILITIES IN THE AREA, EITHER IN SERVICE OR ABANDONED.

LEGEND

C = CURB	MEAS = MEASURED	CABLE TV	COMBINED SEWER	RECHINE	BRONCH MARK	ELECTRIC WALT	QUI POLE	LIGHT POLE	STORM DRAIN MANHOLE	UTILITY POLE
C.L. = CHAIN LINK	N.F. = NORTH FACE	CONC. = CONCRETE	OH. = OVERHEAD	P = PARALLEL	BLUMPER GUARD	ELECTRIC CONTROL BOX	NET	MAIL BOX	STORM SEWER MANHOLE	WALL HYDRANT
OS = DOWN SPOUT	E.F. = EAST FACE	REC. = RECORD	REC. = RECORD	REC. = RECORD	CABLE TV CONTROL BOX	FENCE	INLET ROUND	MANHOLE - UNCLASSIFIED	STREET LIGHT	WATER METER WALT
EF = EDGE OF PAVEMENT	S.F. = SOUTH FACE	F = FLOW LINE	T/F = TOP OF SLAB	W = WALK	OVERHEAD WIRES	FIRE HYDRANT	IRON ROD ROUND	PARKING METER	TELEPHONE WALT & COMMUNICATION	WATER METER WALT
F/F = FINISH FLOOR	1/2 = TOP OF FOUNDATION	G = GROUND	W = WALK	WF = WEST FACE	SANITARY SEWER	GAS MANNHOLE	IRON PIPE ROUND	PAV. SET	TRAFFIC CONTROL BOX	WATER VALVE WALT
LA = IRON PIPE	WF = WEST FACE	LA = IRON PIPE	WF = WEST FACE		WATERMAIN	CLEAN OUT	IRON PIPE SET	TRAFIC LIGHT	TRAFFIC SIGNAL POLE	WATER VALVE WALT
					PROPERTY LINE	COMBINED SEWER MANHOLE	CROSS ROUND & SET	GUARD RAIL		YARD LIGHT

LEGEND

EXISTING GRAVEL EDGE	PROPOSED GRAVEL DRIVEWAY EDGE	EXISTING GRAVEL DRIVEWAY EDGE	PROPOSED GRAVEL DRIVEWAY EDGE
SURFACE WATER FLOW	PROPOSED CONCRETE DRIVEWAY EDGE	EXISTING GRAVEL DRIVEWAY	PROPOSED CONCRETE DRIVEWAY
EXISTING GRAVEL DRIVEWAY	PROPOSED CONCRETE DRIVEWAY	EXISTING GRAVEL DRIVEWAY	PROPOSED CONCRETE DRIVEWAY

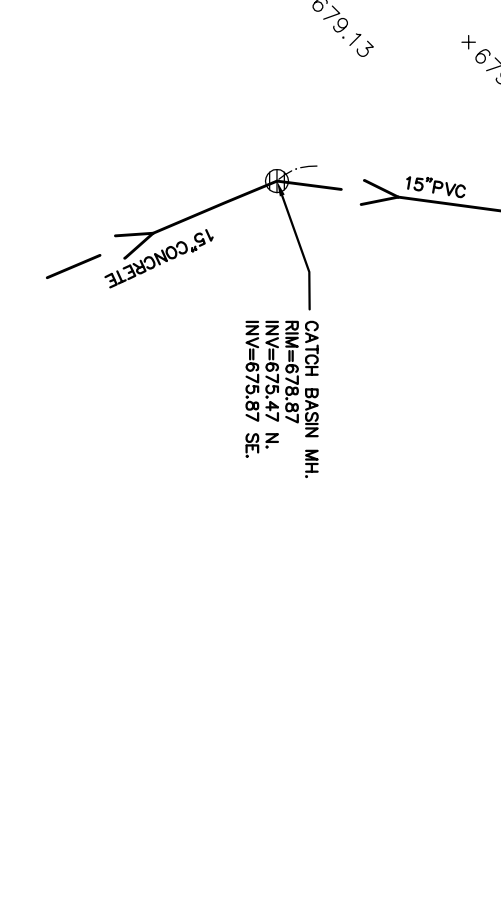

BEARINGS ARE SHOWN FOR ANGULAR REFERENCE ONLY AND ARE NOT RELATED TO TRUE OR MAGNETIC NORTH.

NO.	DATE	DESCRIPTION	BY
5			
4			
3			
2			
1			

WARNING
CALL BEFORE YOU DIG

1 (800) 886-0123
48 HOURS BEFORE
150' DIA.

CALL QUOTE TOLL FREE
1 (800) 886-0123
OFFICE: 5805 W. HIGGINS AVE., CHICAGO, IL 60630
DAYS 8AM - 5PM, WEEKENDS 9AM - 5PM

SPIEWAK CONSULTING
PROFESSIONAL DESIGN FIRM
5805 W. HIGGINS AVE., CHICAGO, IL 60630
phone: (773) 853-2872, fax: (773) 736-4816
www.landsurveyors.pro
andrew@landsurveyors.pro

SITE PLAN

ORDERING: 094-13

SCALE: 1" = 10'

SHEETING: 1 OF 1